
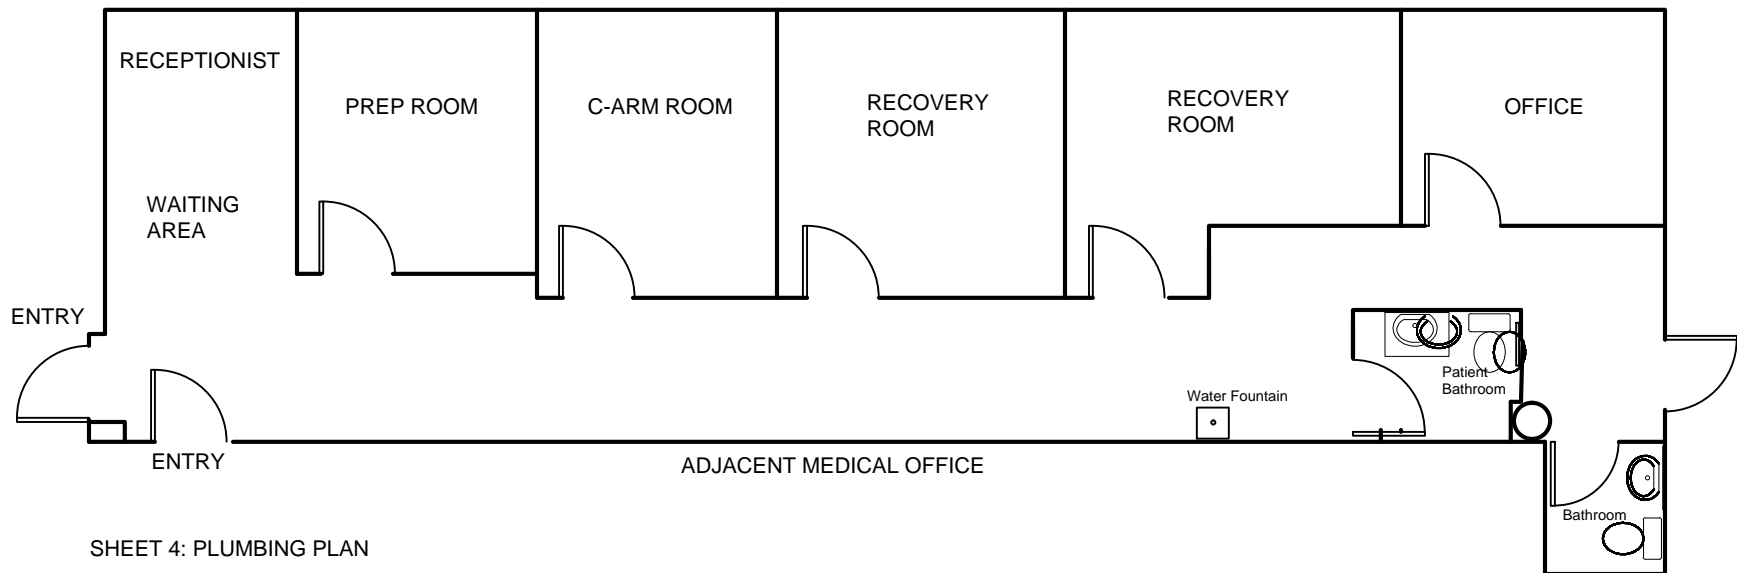


PLUMBING RISER

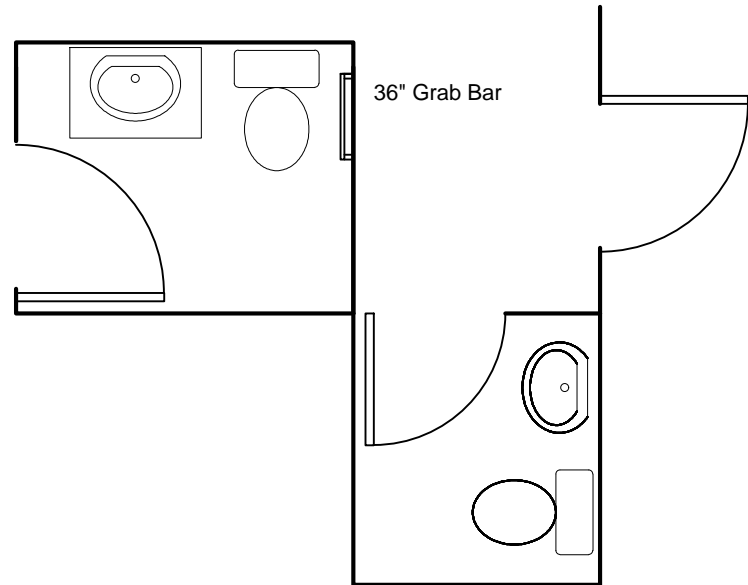

SHEET 4: PLUMBING PLAN

JOB LOCATION	DRAWN BY	ENGINEER	
1391 N. MILITARY TRAIL	ROBERT BARKER	ALAN TINDELL - PE #63135	
WEST PALM BEACH, FL 33409	8590 S.E. WILKES PLACE	603 CURLEW RD.	
OWNER: DR. CHARLES MITZELFELD	HOBE SOUND, FL 33455	DELRAY BEACH, FL 33444	
Ph. 561-684-0333	Ph. 561-282-8301		