



MECHANICAL PLAN
SCALE: 1/4" = 1'-0"

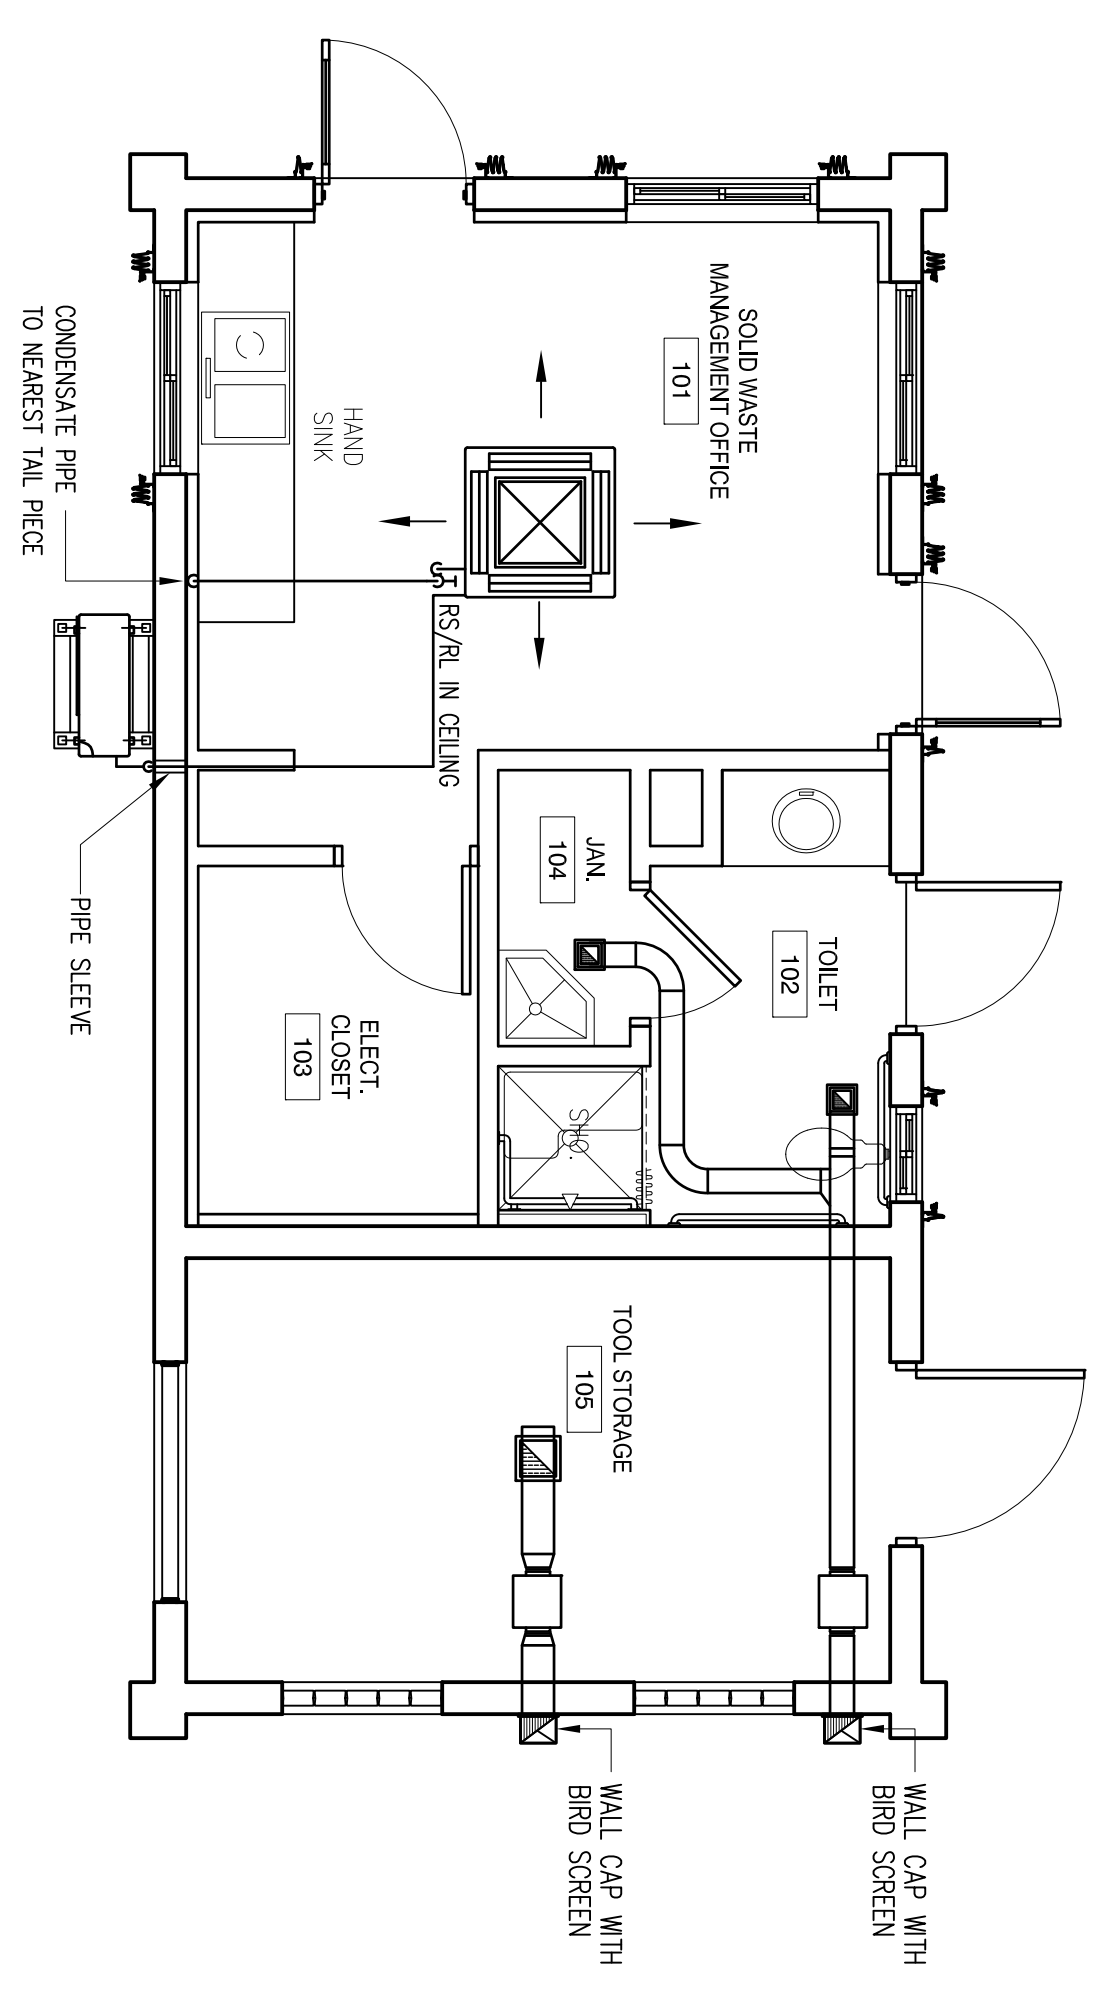

MECHANICAL PLAN
SCALE: 1/4" = 1'-0"

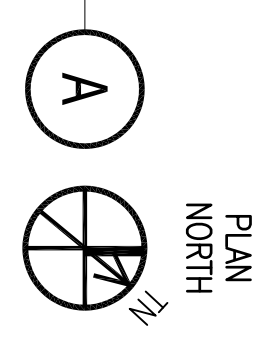