



 



 
 



 

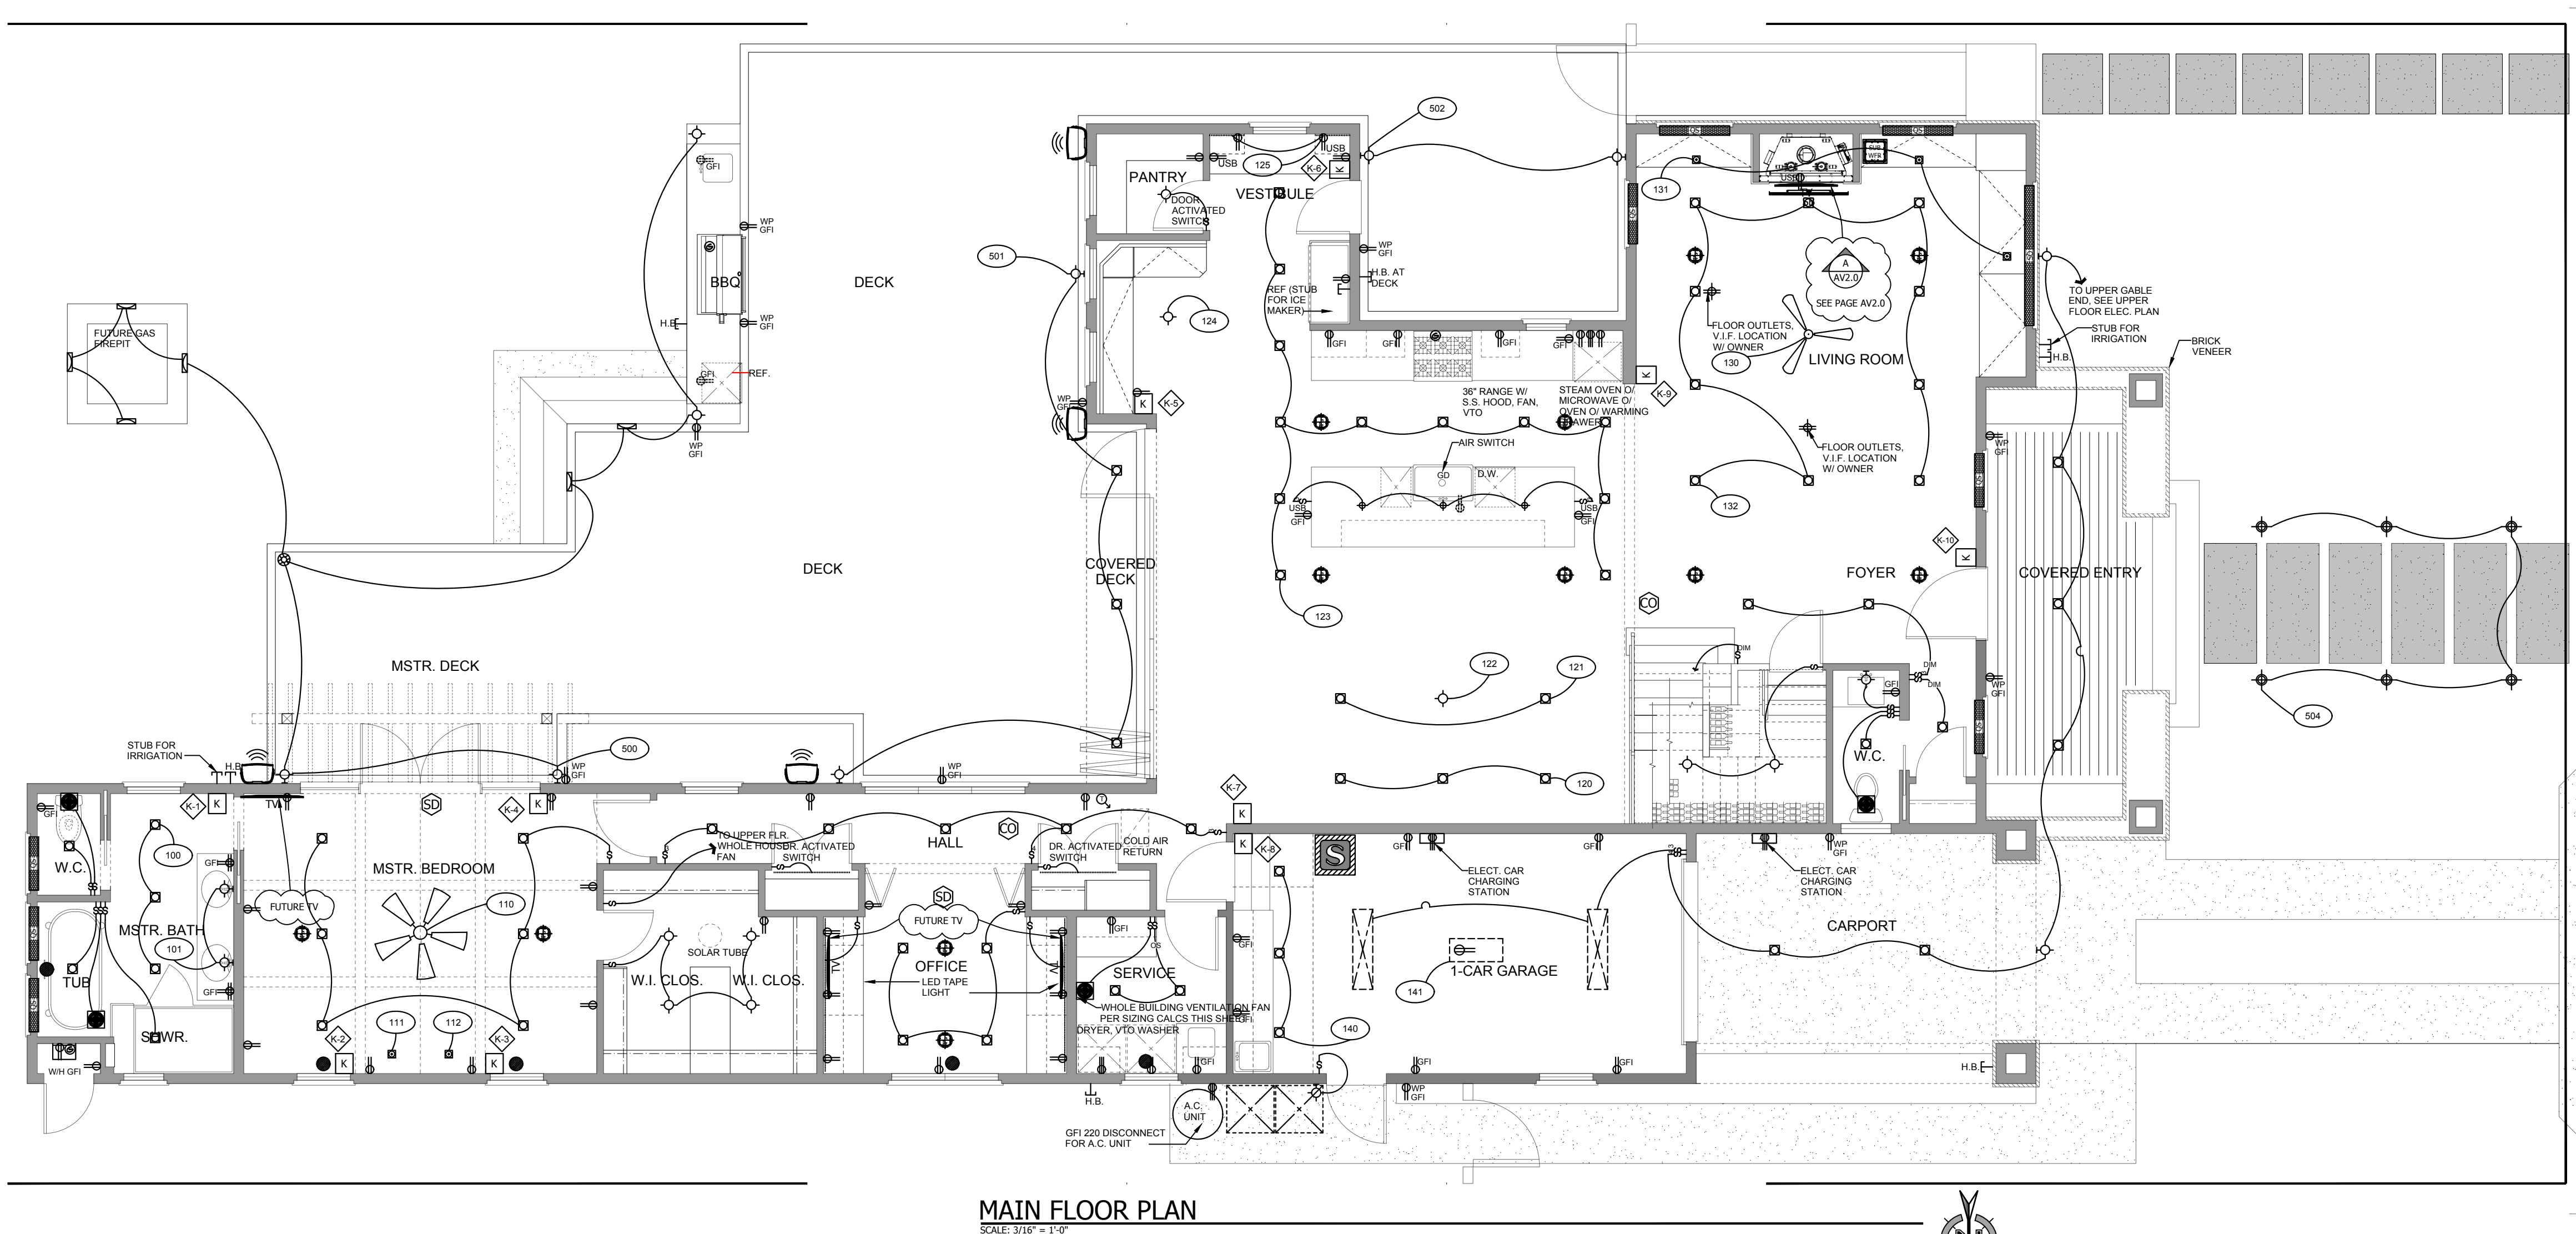


LV SYMBOL LEGEND	
	KEYPAD
	SMOKE DETECTOR / ALARM
	CARBON MONOXIDE DETECTOR / ALARM
	EXHAUST FAN
	LUTRON SHADE
	KEYPAD NUMBER ASSIGNMENT
	SWITCH LEG NUMBER ASSIGNMENT

AV SYMBOL LEGEND	
	AV EQUIPMENT RACK 20 AMP DEDICATED CIRCUIT(S) REQUIRED
	TV / DISPLAY & MOUNTED LOCATION
	SOUNDBAR
	SPEAKER, IN CEILING ROUND
	SPEAKER, IN WALL
	SPEAKER, SUBWOOFER
	KEYPAD NUMBER ASSIGNMENT
	SWITCH LEG NUMBER ASSIGNMENT



BY: TNT ELECTRIC
BRIAN TONOLE
CELL: 707-292-1711
OFFICE: 707- 837-0147
EMAIL : ravendesign@tnt-electric.net
LIC# C699955

REVISION:

PROJECT: PIMPA AND PAKORN TARA RESIDENCE

ADDRESS:
720 JOHNSON STREET
HEALDSBURG, CA 95448
APN:002-053-006

 



 


DATE:
8/13/2018





 


SCALE:
3/16"=1'-0


DRAWN BY: BB
CHECKED BY: BT

SHEET:
AV1.0


www.tnt-electric.net
Lic. C699955
707-292-1711

LV SYMBOL LEGEND	
	KEYPAD
	SMOKE DETECTOR / ALARM
	CARBON MONOXIDE DETECTOR / ALARM
	EXHAUST FAN
	LUTRON SHADE
	KEYPAD NUMBER ASSIGNMENT
	SWITCH LEG NUMBER ASSIGNMENT

AV SYMBOL LEGEND	
	A/V EQUIPMENT RACK 20 AMP DEDICATED CIRCUIT(S) REQUIRED
	TV / DISPLAY & MOUNTED LOCATION
	SPEAKER, IN CEILING ROUND
	SPEAKER, IN WALL
	SPEAKER, SUBWOOFER
	KEYPAD NUMBER ASSIGNMENT
	SWITCH LEG NUMBER ASSIGNMENT

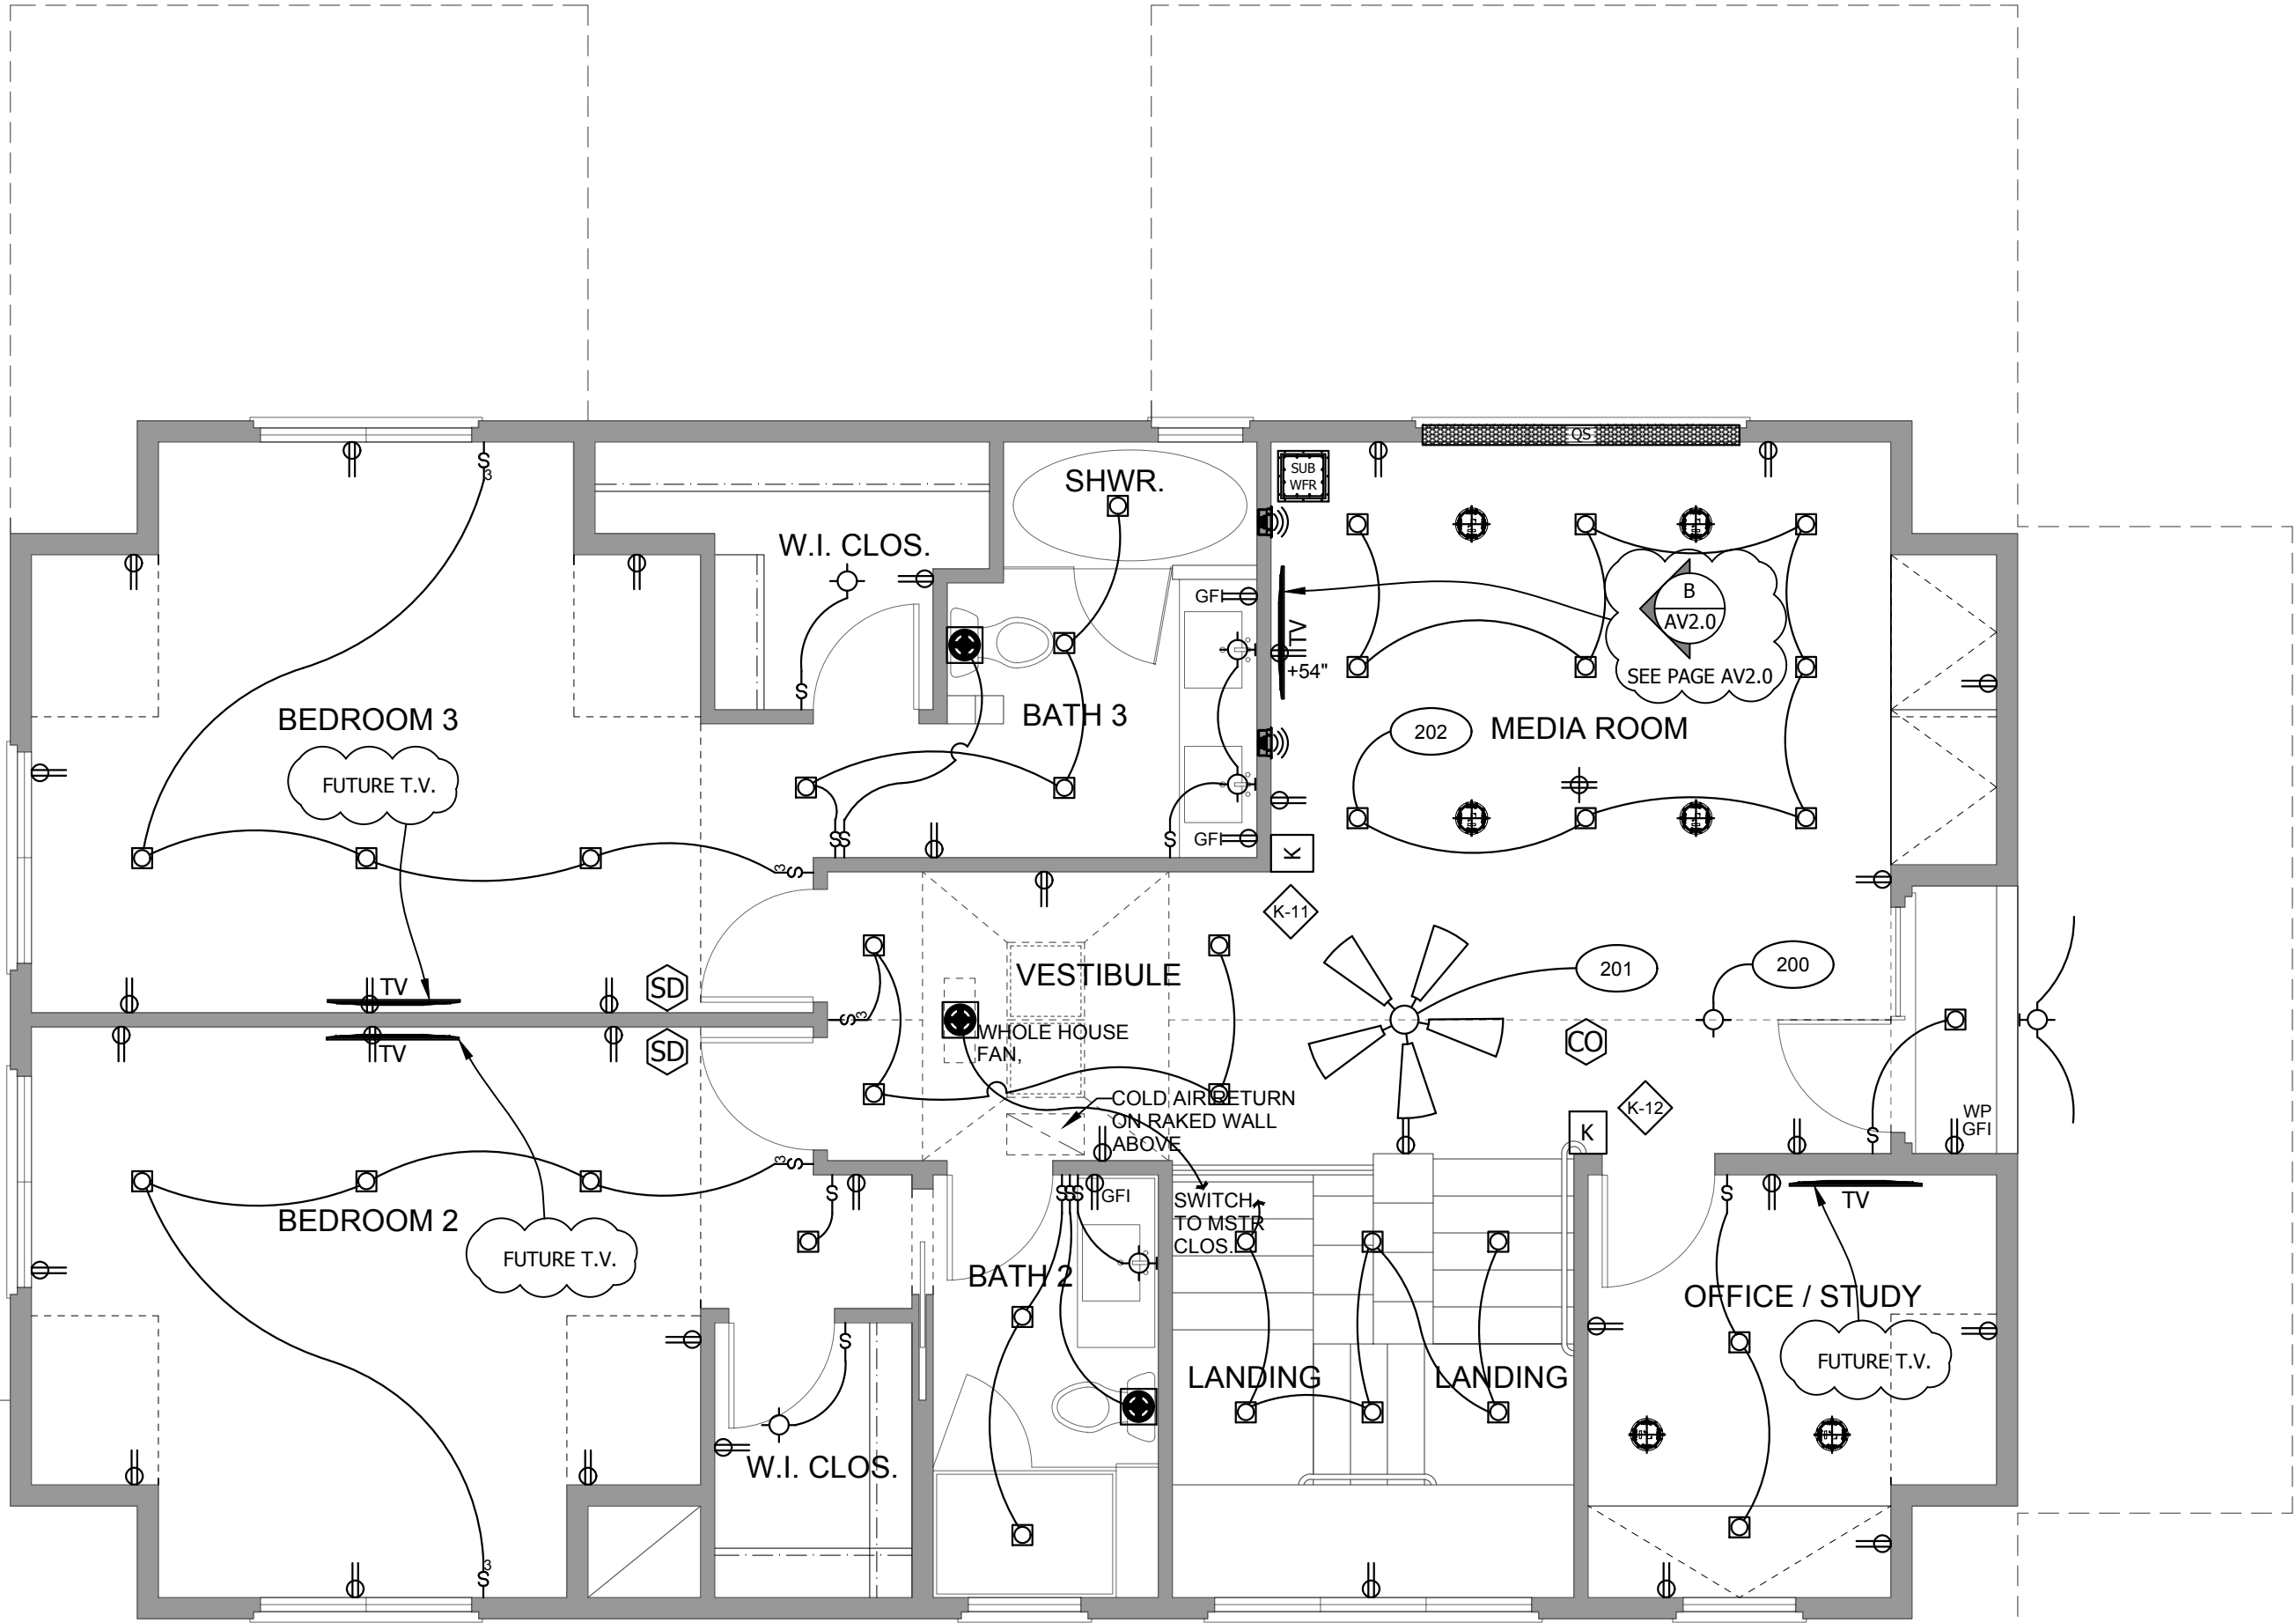

UPPER FLOOR PLAN
SCALE: 1/4" = 1'-0"

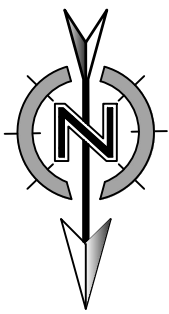

BY: TNT ELECTRIC
BRIAN TONOLE
CELL: 707-292-1711
OFFICE: 707- 837-0147
EMAIL : ravendesign@tnt-electric.net
LIC# C699955

REVISION:

PROJECT: PIMPA AND PAKORN TARA RESIDENCE

ADDRESS:
720 JOHNSON STREET
HEALDSBURG, CA 95448
APN:002-053-006


DATE:
8/13/2018

SCALE:
1/4"=1'-0

DRAWN BY: BB
CHECKED BY: BT

SHEET:
AV1.1

www.tnt-electric.net
707-292-1711
Lic. C699955

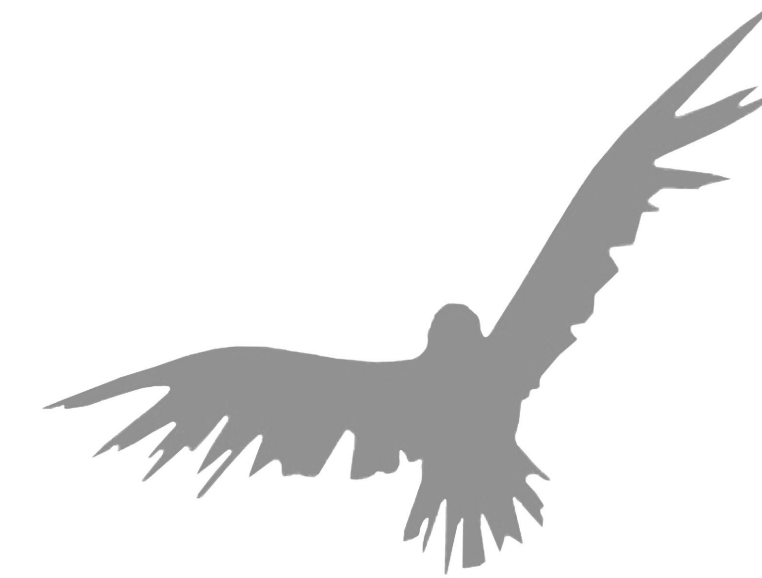

TNT

Audio
ELECTRIC
Automation

Video
ELECTRIC

“Control Your Environment”

www.tnt-electric.net
707-292-1711
Lic. C699955



BY: TNT ELECTRIC
BRIAN TONOLE
CELL: 707-292-1711
OFFICE: 707- 837-0147
EMAIL : ravendesign@tnt-electric.net
LIC# C699955

REVISION:



SOUTH


SOUTH

SOUTH


A NOOK ELEVATION
SCALE: 1/2" = 1'-0"

KITCHEN ELEVATION

LIVINGROOM ELEVATION

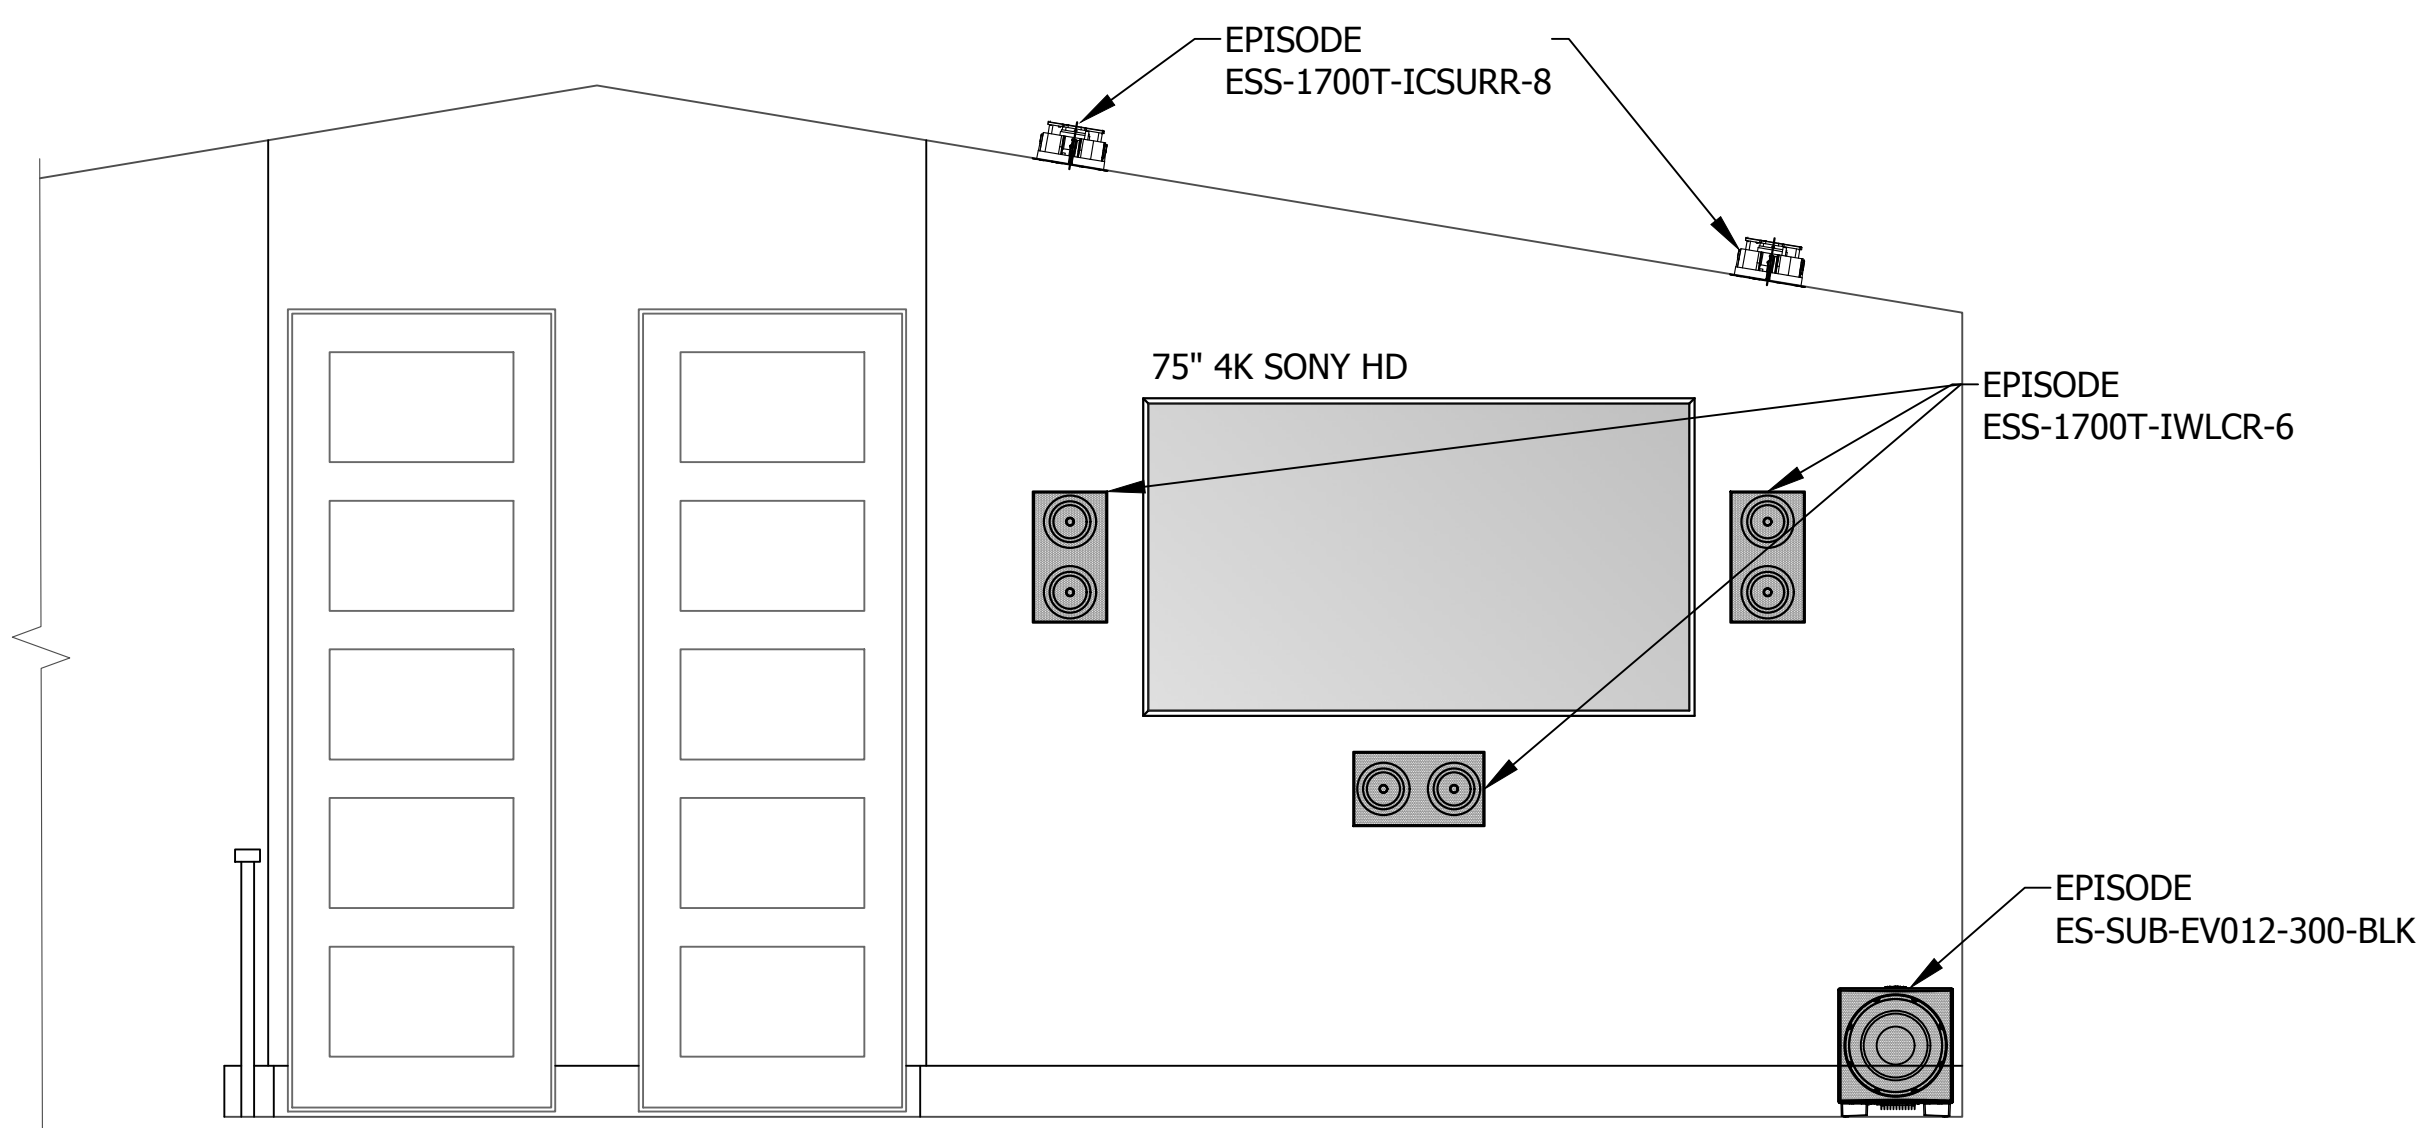

B MEDIA ROOM ELEVATION (OPTION A)
SCALE: 3/16" = 1'-0"

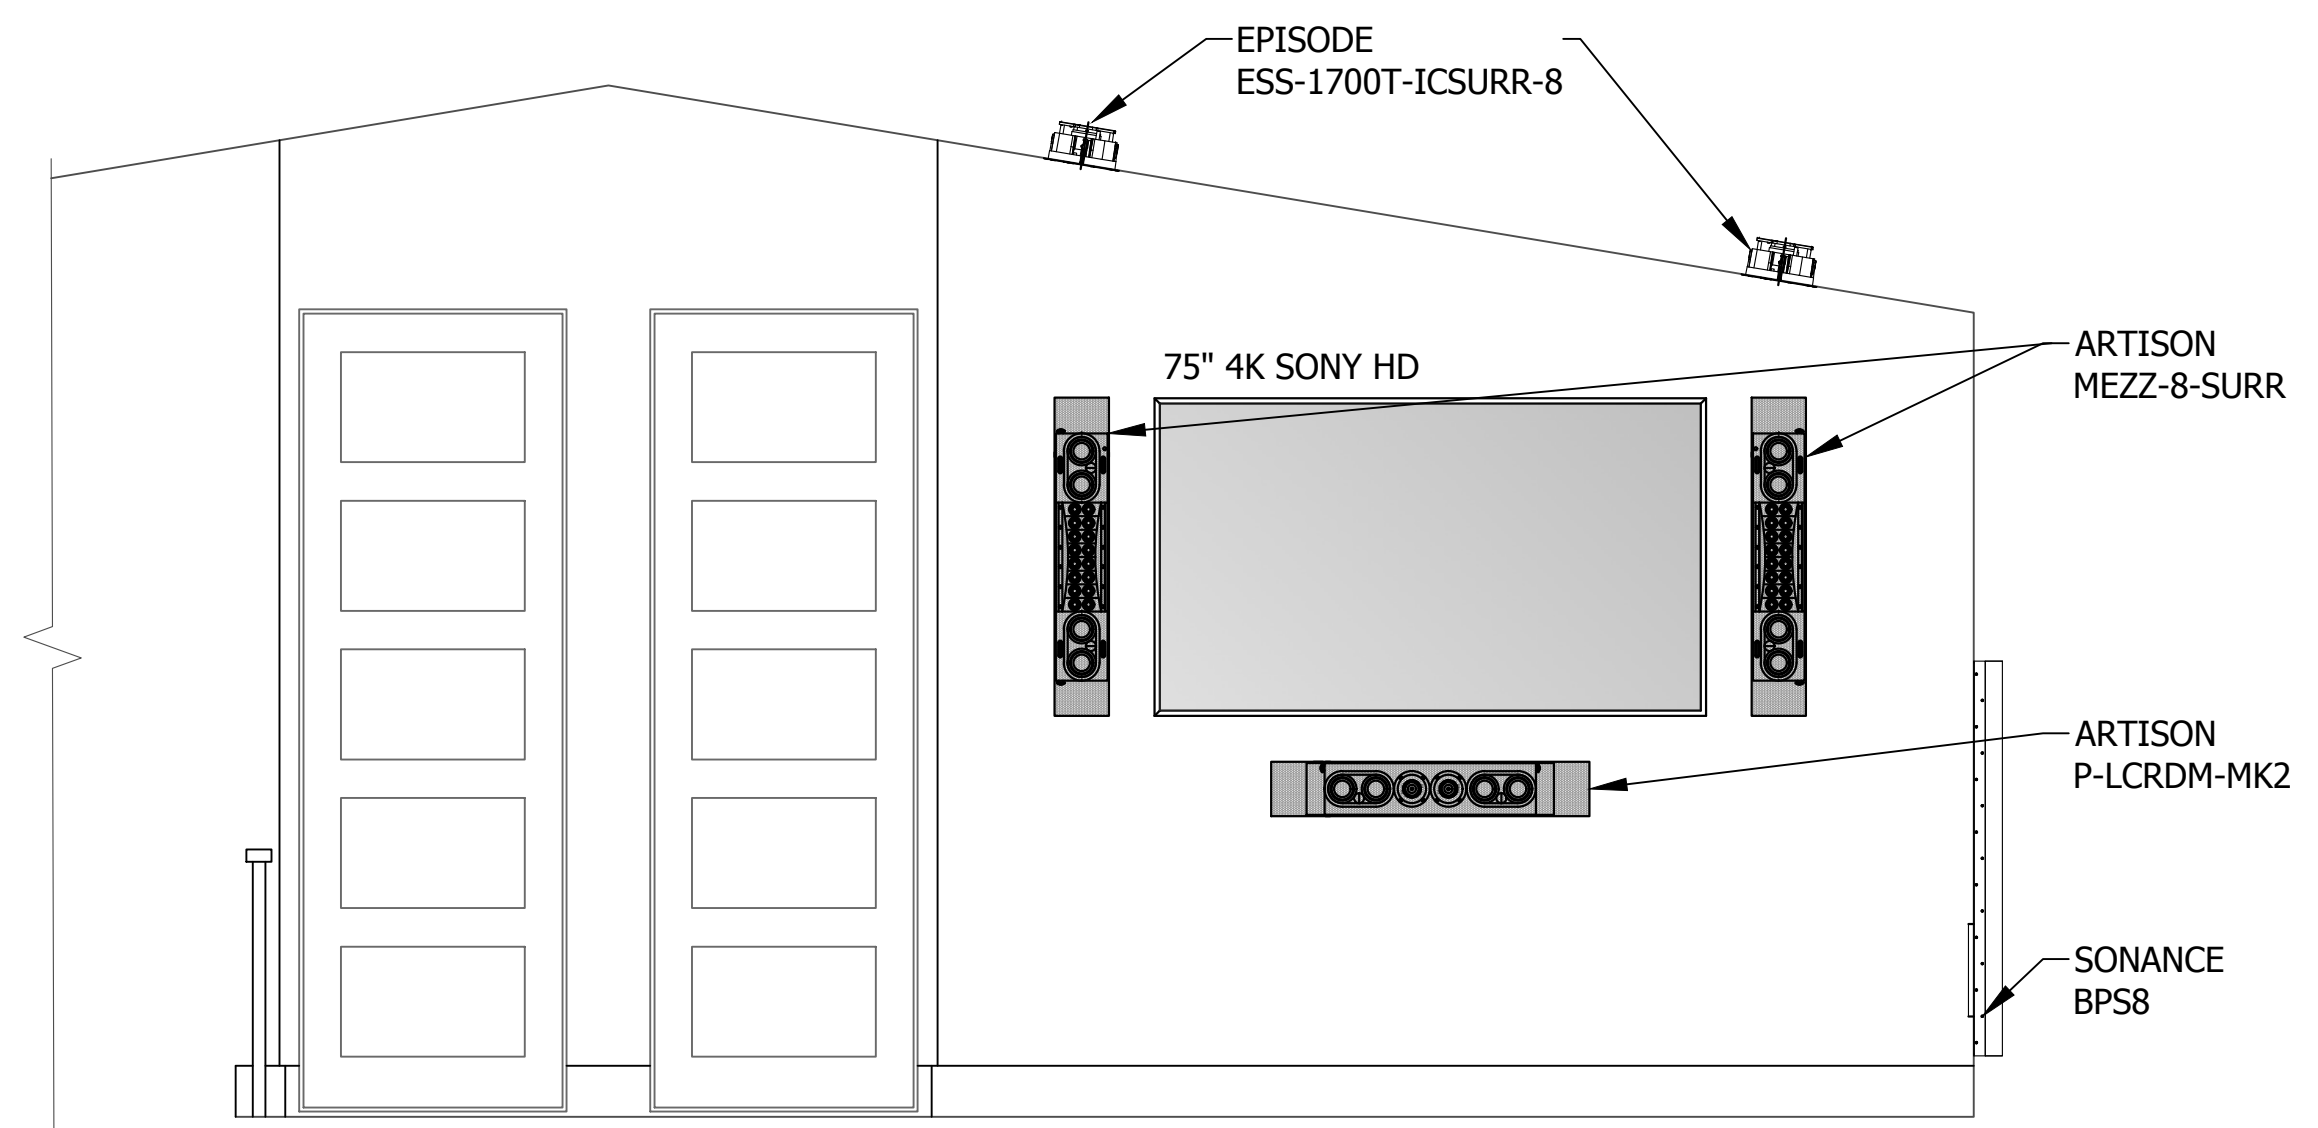

B MEDIA ROOM ELEVATION (OPTION B)
SCALE: 3/16" = 1'-0"

PROJECT: PIMPA AND PAKORN TARA RESIDENCE

ADDRESS:
720 JOHNSON STREET
HEALDSBURG, CA 95448
APN:002-053-006

DATE:
8/13/2018

SCALE:
1/2"=1'-0

DRAWN BY:
BB

CHECKED BY:
BT

SHEET:
AV2.0